
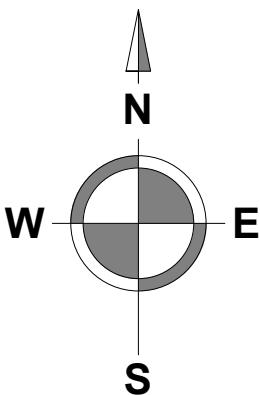


DO NOT SCALE - IF IN DOUBT ASK

GENERAL NOTES

This drawing is to be read in conjunction with all relevant Partington & Associates , architects, service engineers and subcontractor drawings

Review all drawings and report any discrepancies to Partington & Associates prior to commencement.

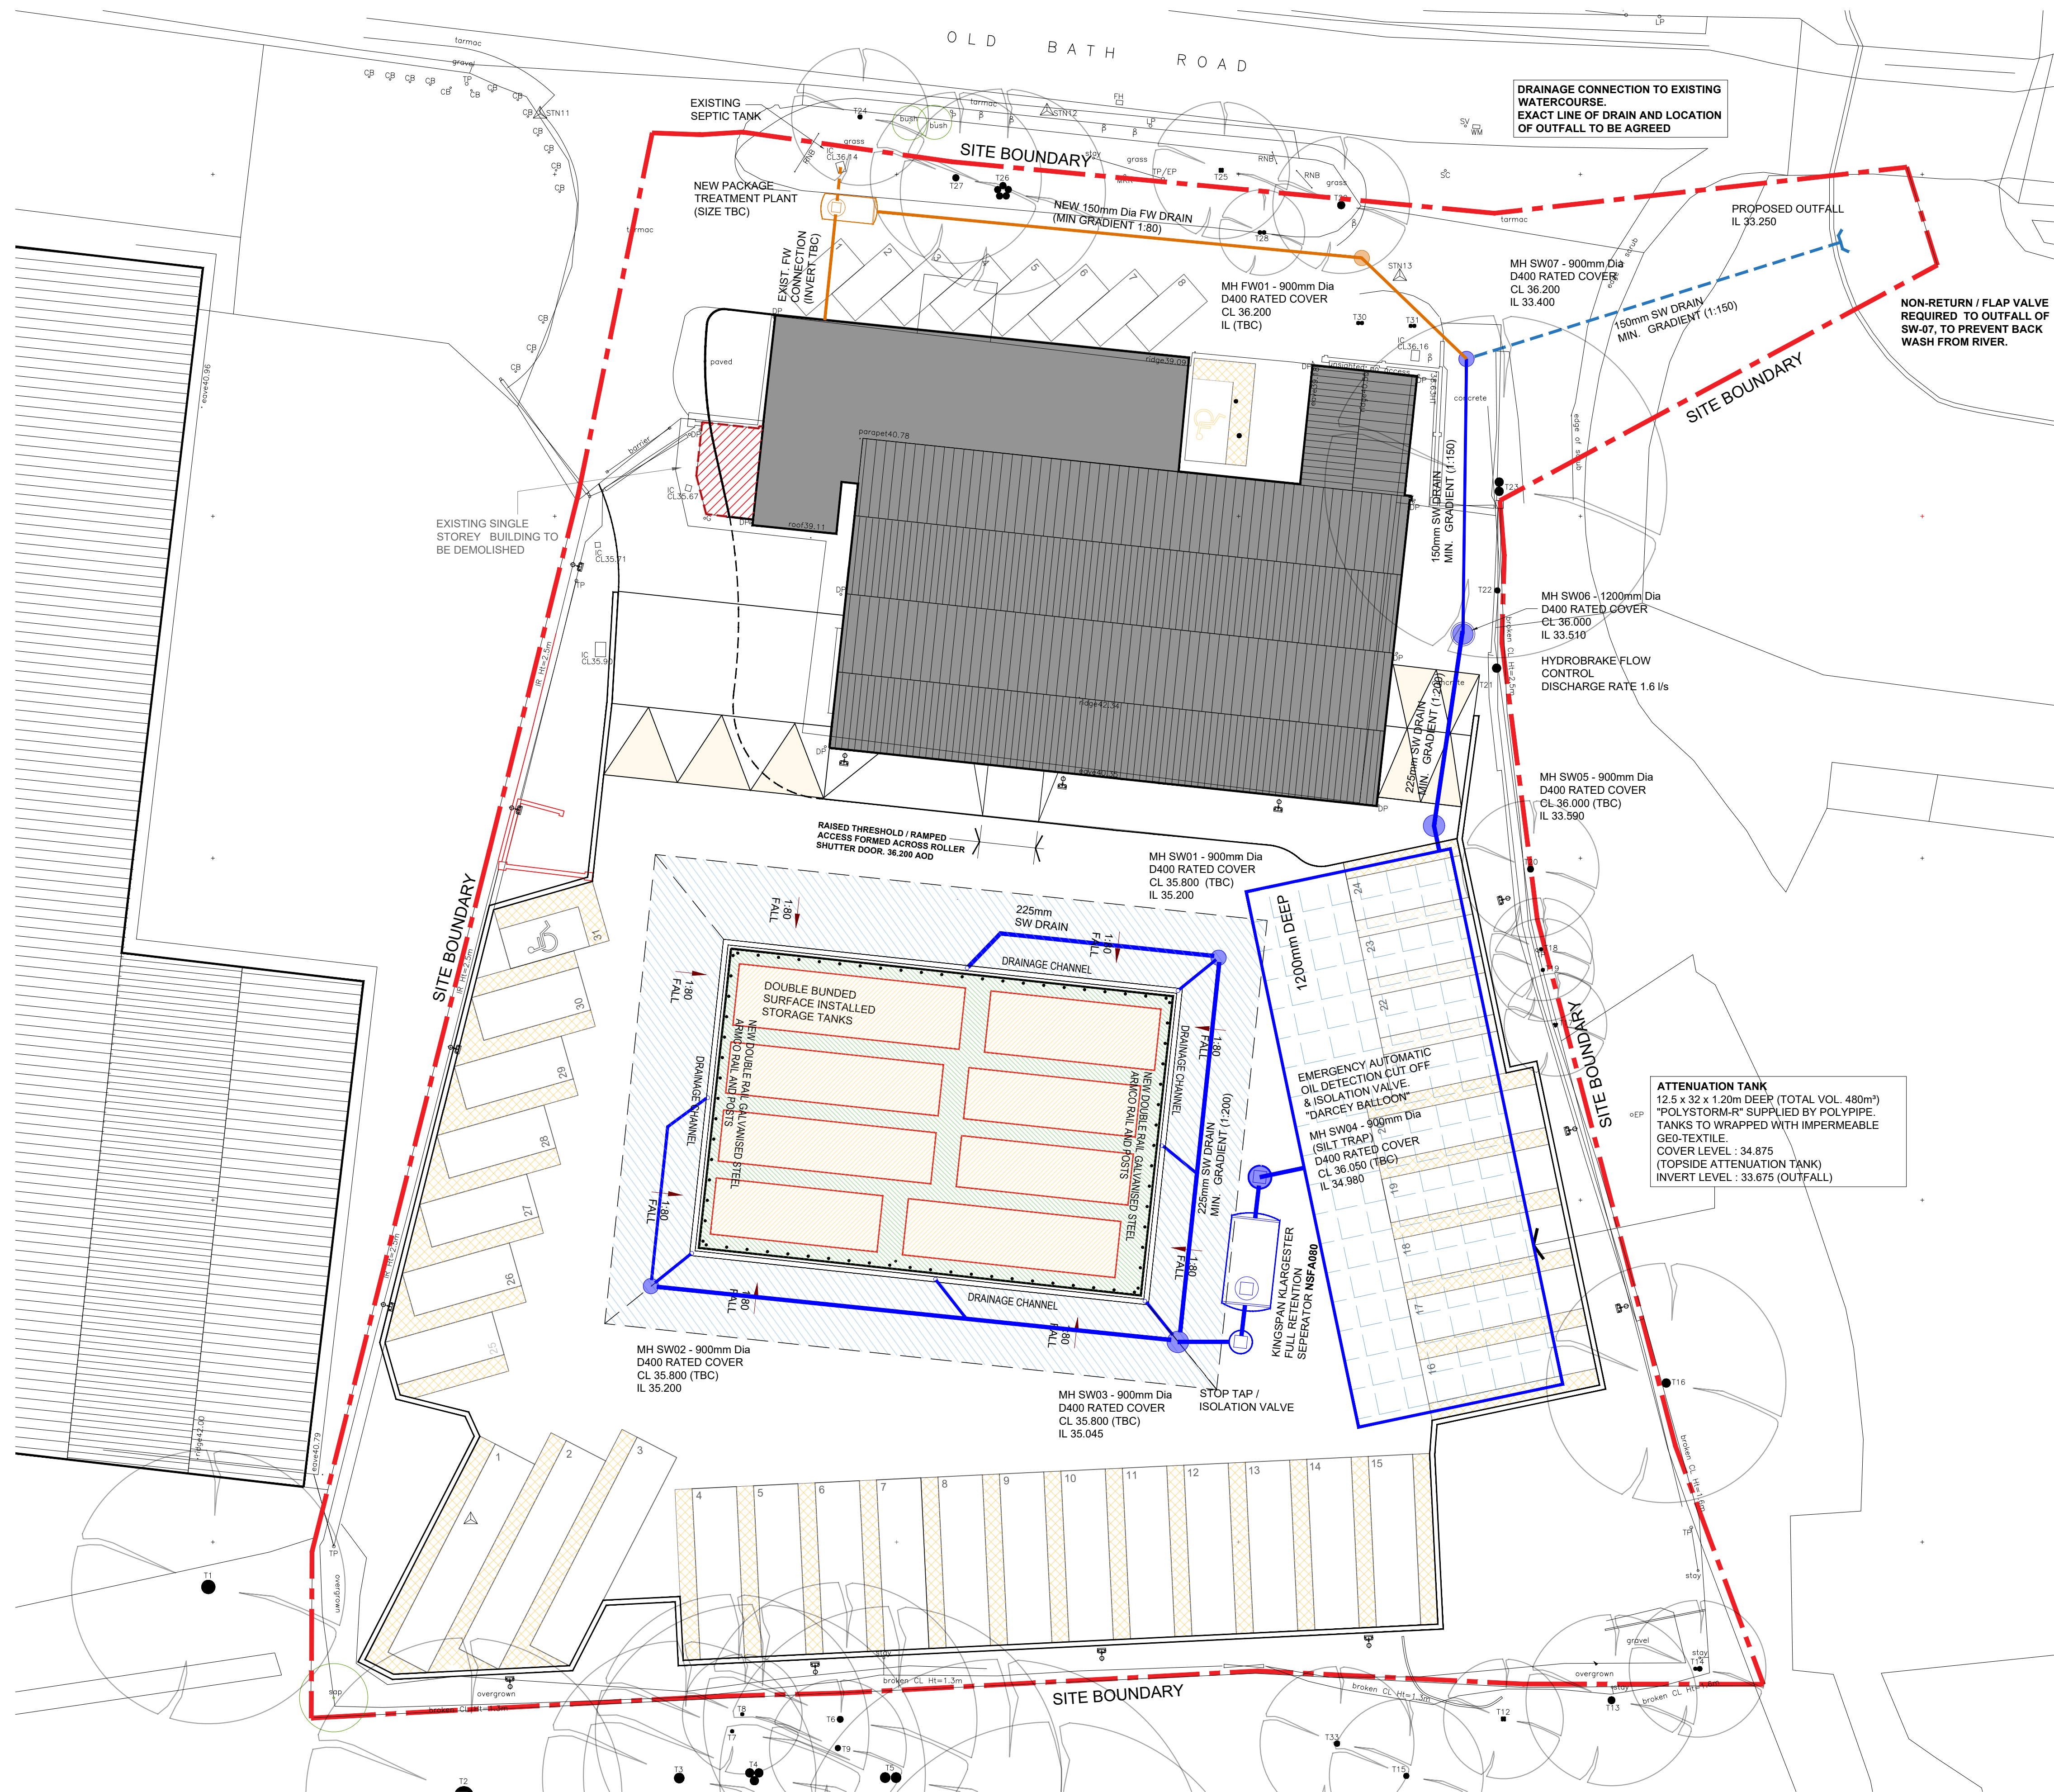

DRAINAGE LAYOUT

(SCALE 1:200)



FOR APPROVAL				
Revision	By	Check	Date	Description
 Partington Associates Partington & Associates Limited Structural Design Consultants 13 Gillibrand Street Chorley Lancashire PR7 2EJ Tel: 01257 249863 e-mail: admin@partington-associates.com www.partington-associates.com				
Client	SPEEDY FUELS & LUBRICANTS LTD.			Scale @A1
Project	OLD BATH ROAD CHARVIL READING (RG10 9QJ)			Date
				Drawn
Title	PROPOSED DRAINAGE LAYOUT			Check
Job No.	5104-24	Dwg No.	70	Rev.
				Approved
				1:200 / 1:100
				MAR'25
				MW
				DO
				-