

Project Name - Carnival Apartments Wokingham

Detail - Exterior Lighting

Scheme Number - Rev 9

Date - 08.07.25

Perpared By - Katy Smith

Contact Name - Josh Bell


Customer - Entric Services

Contact - Stuart Simmonds

Tel - 0118 933 1563

Email - stuart@entric.co.uk



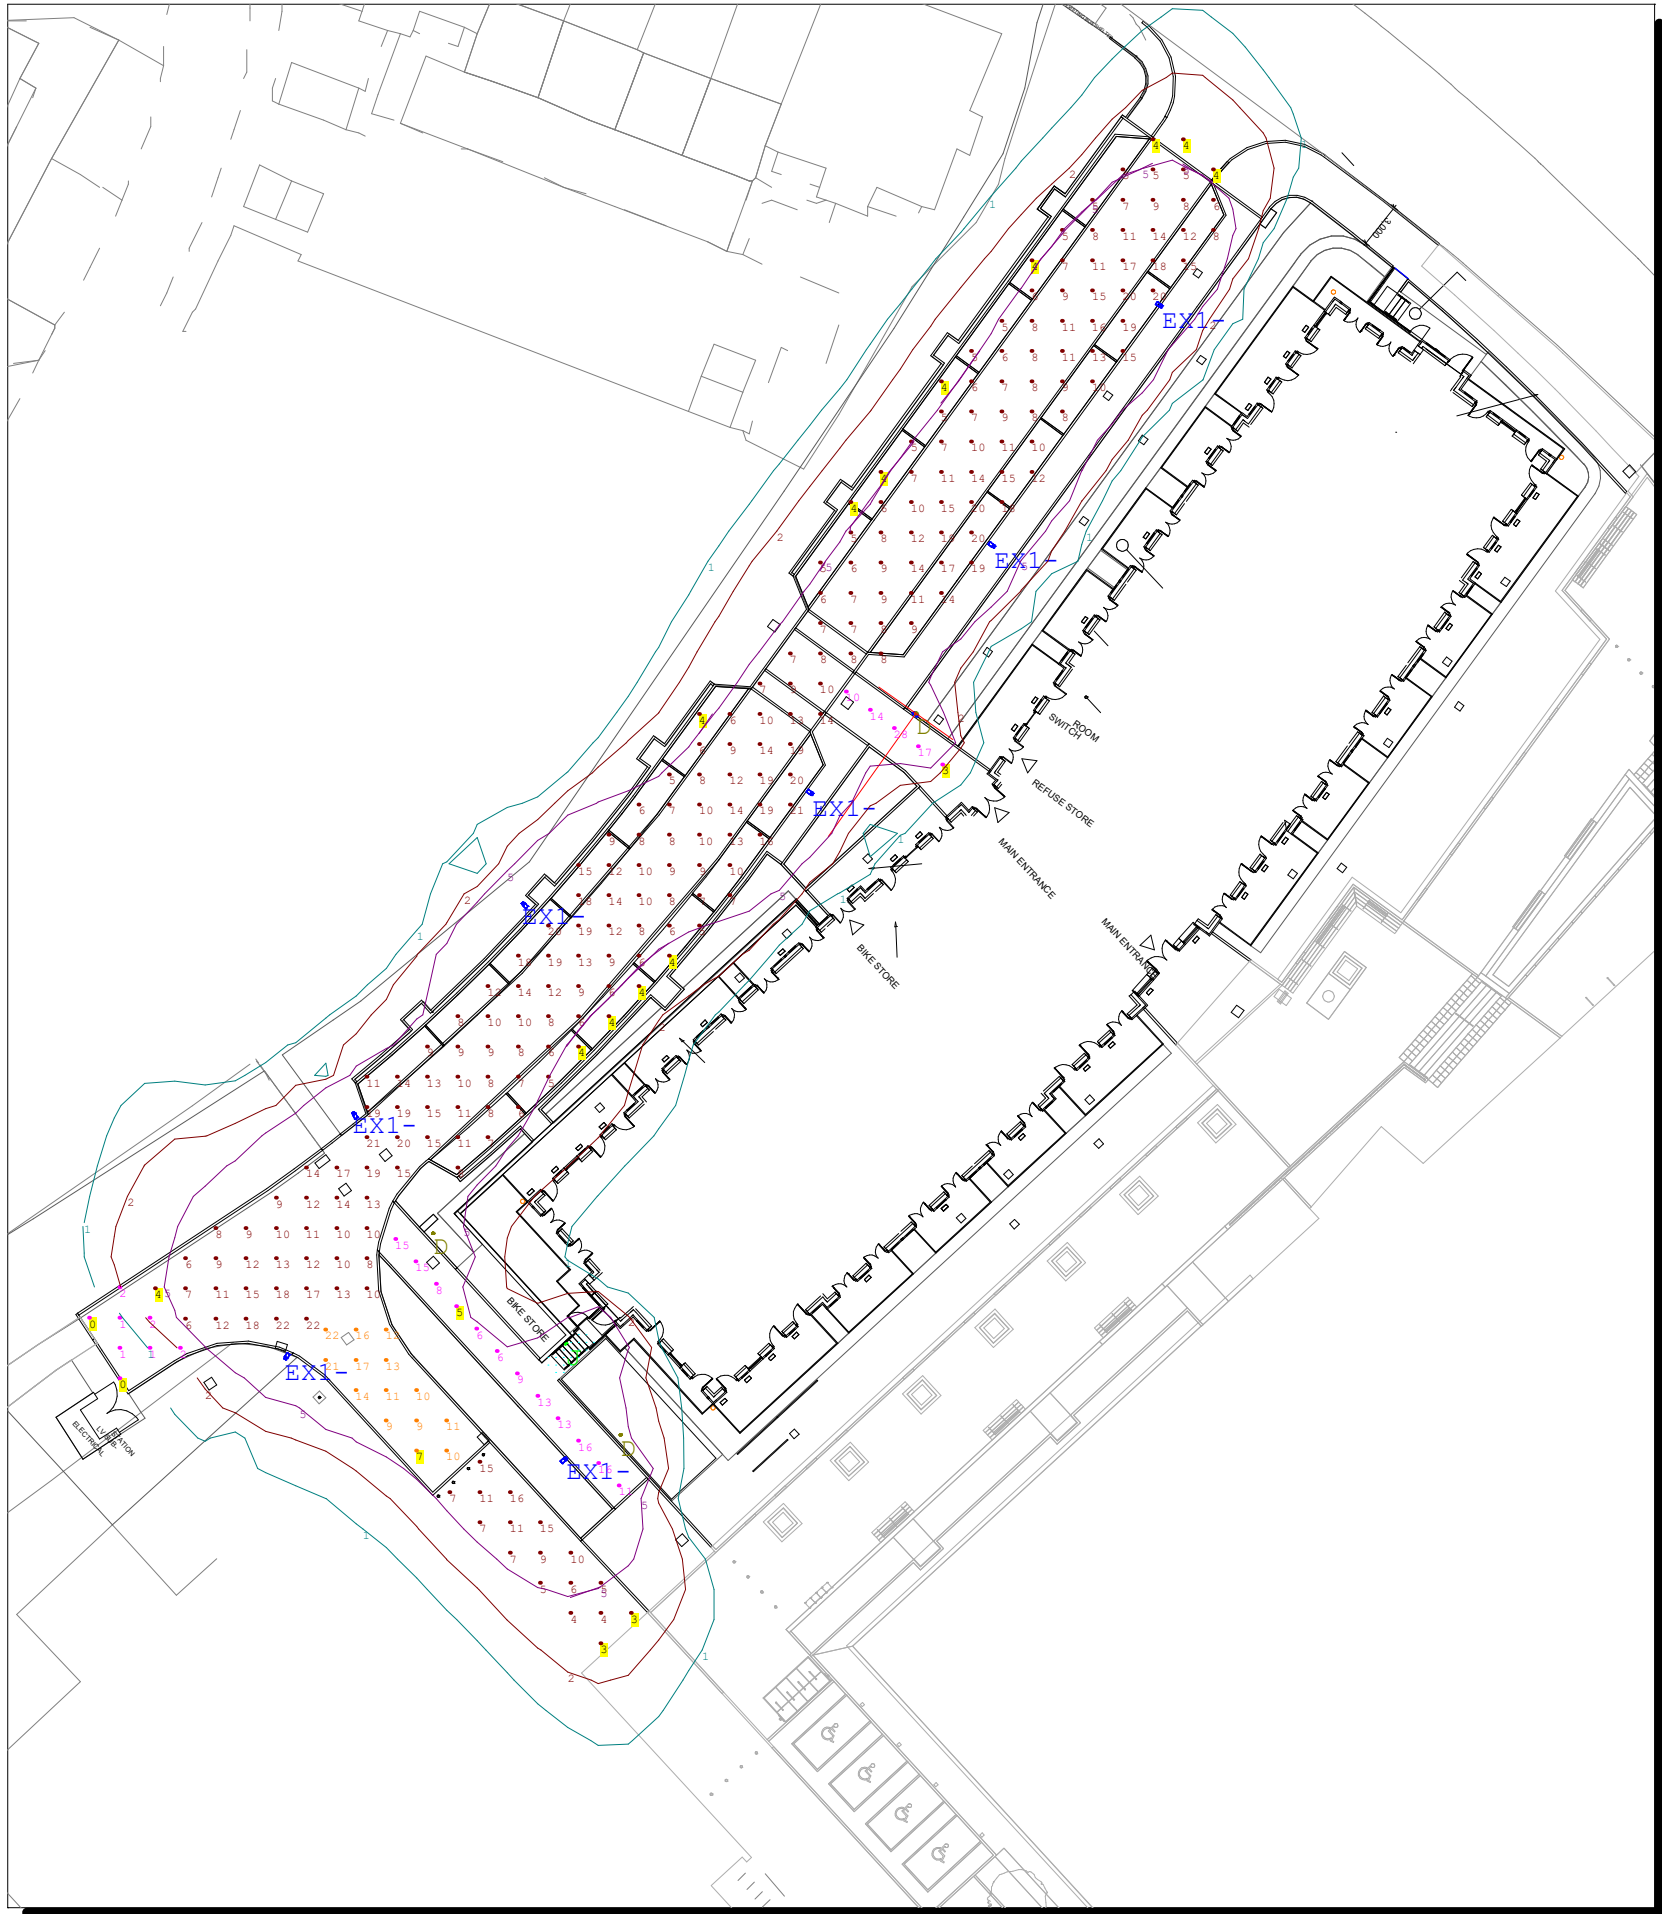

Luminaire Schedule					
Symbol	Qty	Label	Description	LLF	Height
	1	J	WE-EF RLS410 [R45.4K] 3LED 9W (131-9963)	0.800	2m
	7	EX1-	WE-EF VFL530 [S65.4K] 12LED 24W (108-1148)	0.800	6m
	3	D	KTY234 [R65.3K] 3LED 13W (114-9087)	0.800	1m

Calculation Summary					
Label	Avg	Max	Min	Min/Avg	Min/Max
Entrance Path	14.40	28	3	0.21	0.11
In Abayance	1.13	2	0	0.00	0.00
Iso Lines	2.55	71	0	0.00	0.00
Lower Path	11.08	16	5	0.45	0.31
Road & Parking	10.55	22	4	0.38	0.18
Road after bollards	8.12	16	3	0.37	0.19
Short side road	13.00	22	7	0.54	0.32
Steps	45.90	65	22	0.48	0.34

Notes:
- Grid values in Lux
- Grid intervals: 2m
- Contour values in Lux
- Contour intervals: 1, 2 & 5 Lux
- Scheme uses customer specified locations



RLS410



KTY234



VFL530

Drawing Title: Carnival Apartments Wokingham	
Drawing Number: Rev 9	
Customer: Entric Services	
Designed By: Katy Smith	
Date: 08.07.25	Scale: 1:500 @ A3



WE-EF LIGHTING UK
33 - 34 Dolben Street
London
SE1 0UQ
Tel: 020 7403 4123
e-mail: info.uk@we-ef